


Runley, Ayco & Associates, Ltd.  
Civil Engineers - Land Planning  
1401 Greystone, Fauquier County, VA  
703-795-3100  
703-795-3101  
703-795-3102  
703-795-3103

GRADING PLAN  
SCALE: 1"=40'-0"  
0" 20' 40'

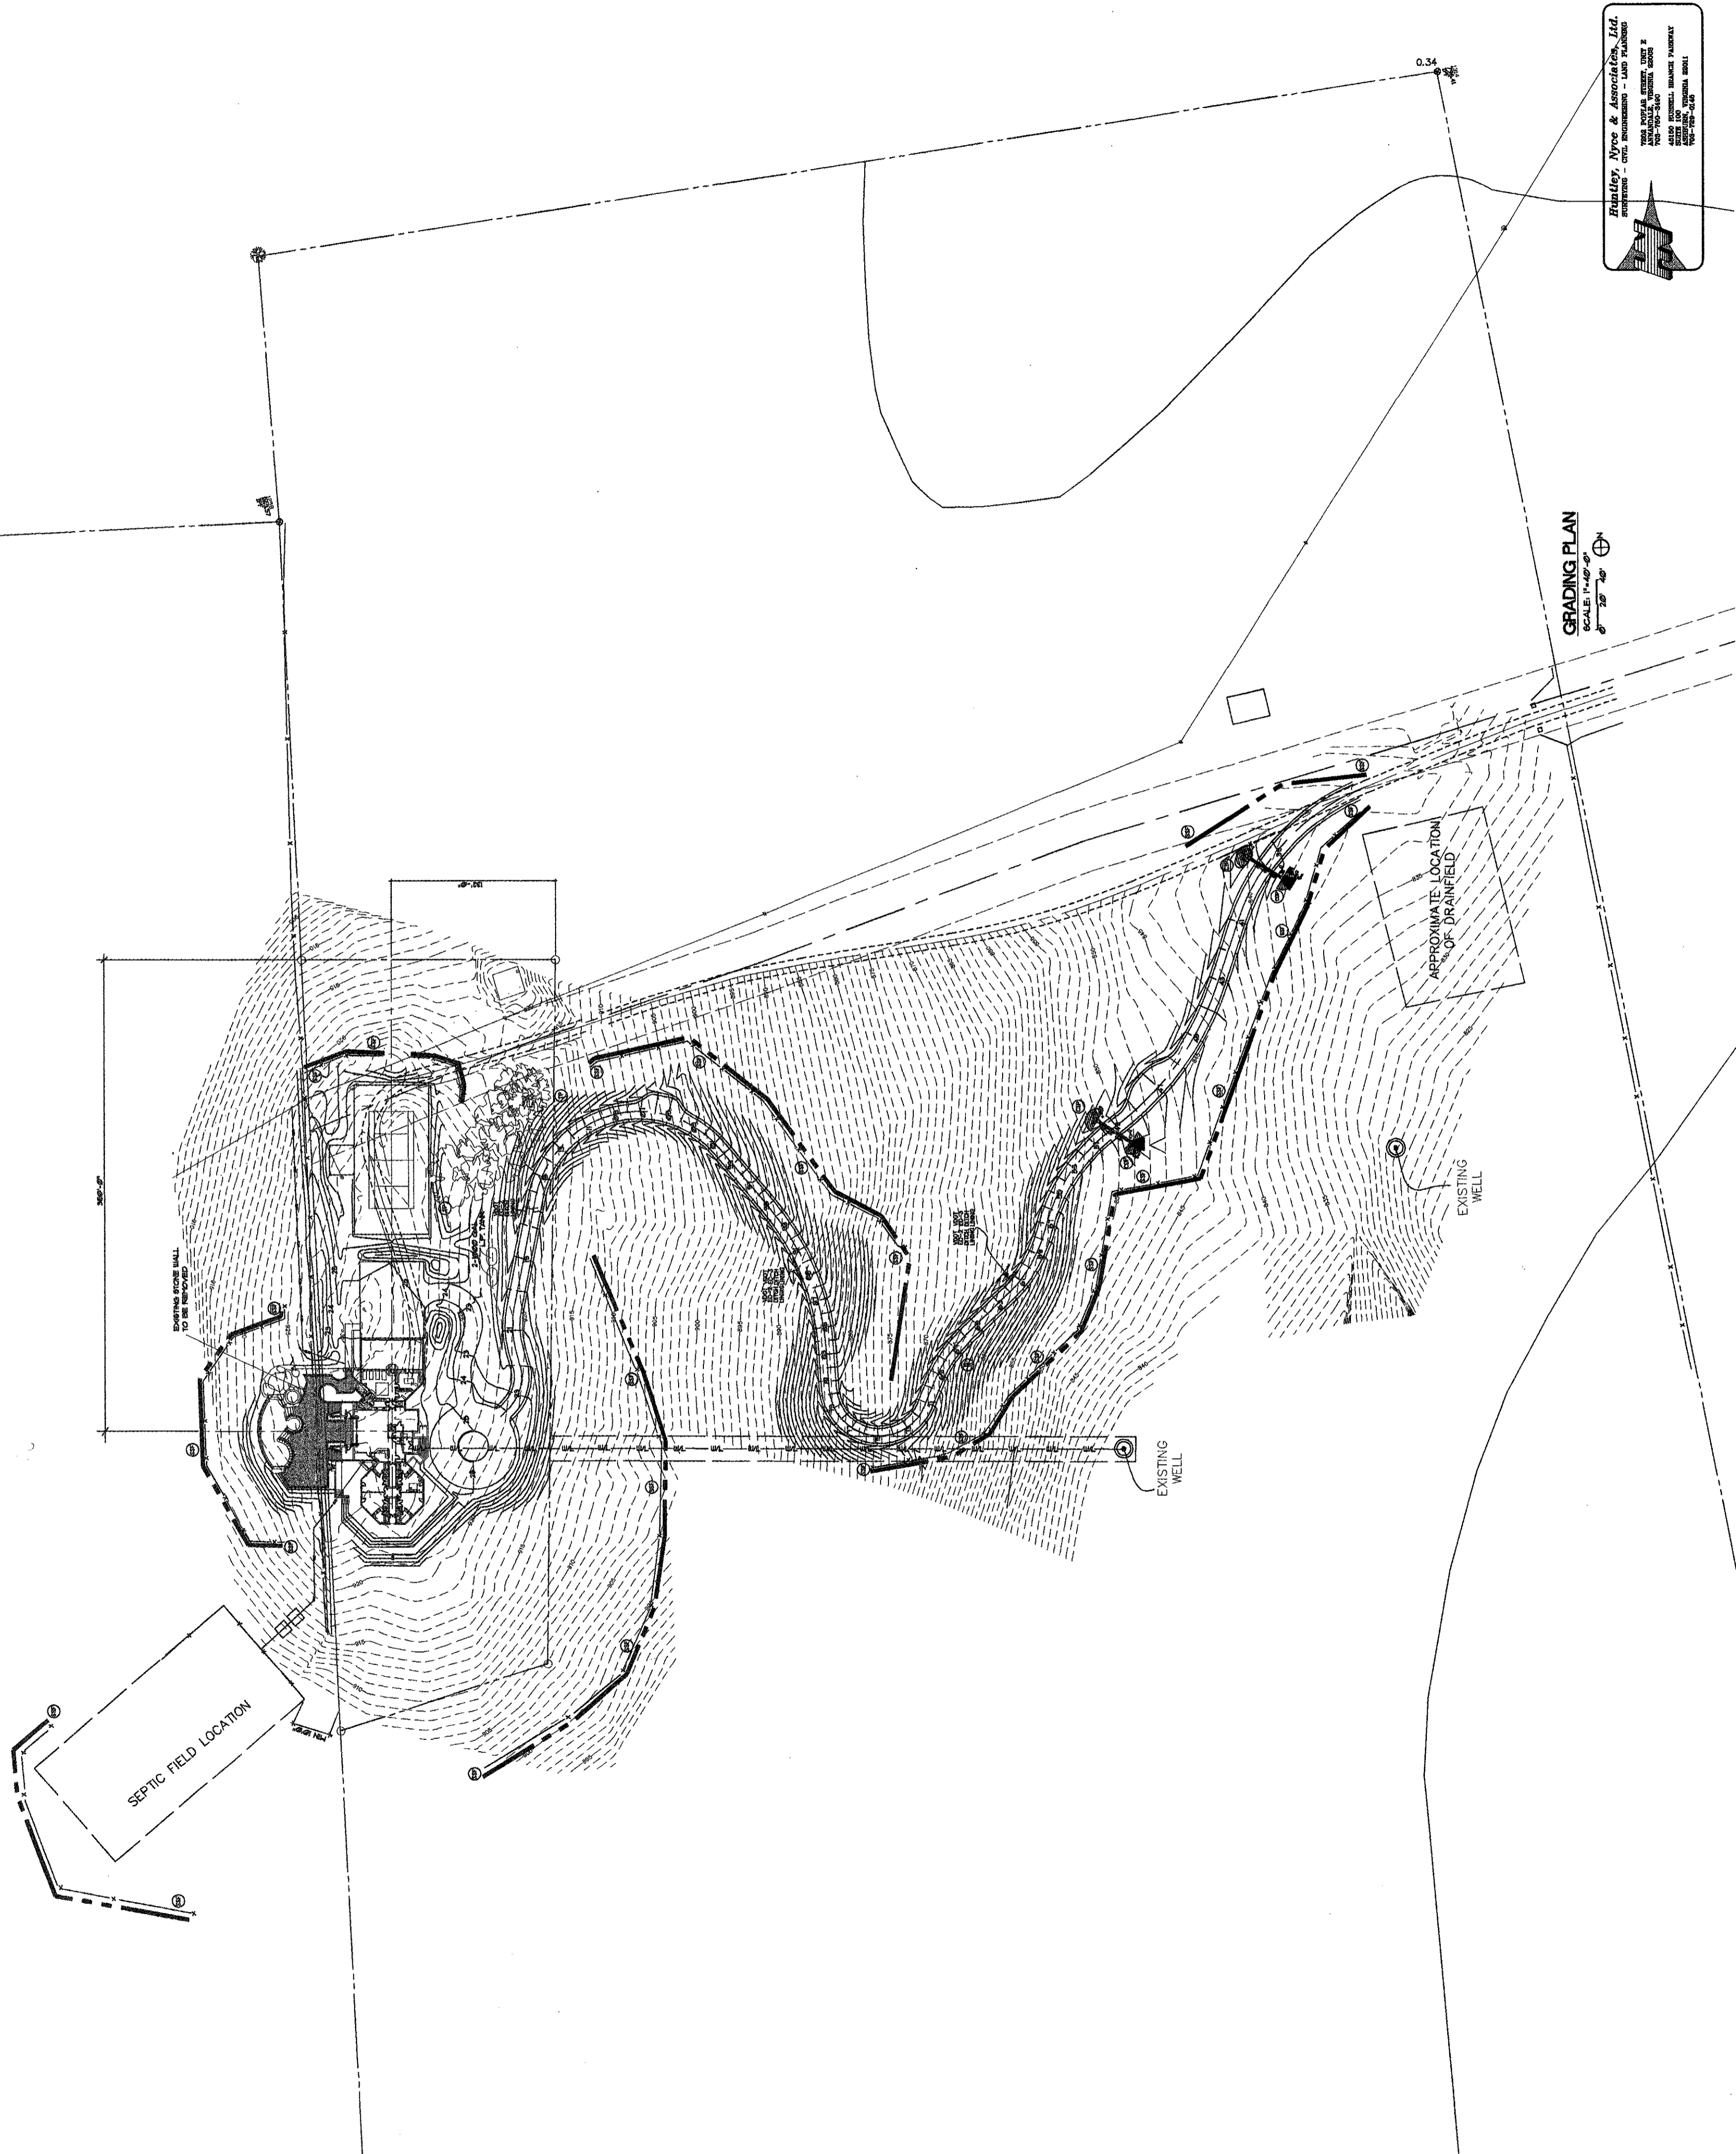

07/22/2004  
09/07/2004  
12/07/2004

CONSTRUCTION SET 4  
CONSTRUCTION SET 2  
CONSTRUCTION SET 5

07/22/2004  
09/07/2004  
12/07/2004

CONSTRUCTION SET 4  
CONSTRUCTION SET 2  
CONSTRUCTION SET 5

1401 Greystone, Fauquier County, VA  
architect michael i. oxman and associates ltd.

SP-2  
2/20/2002

SEPTIC FIELD LOCATION

APPROXIMATE LOCATION OF DRAINFIELD

EXISTING WELL

EXISTING WELL

EXISTING STONE WALL TO BE REMOVED