


**POWER
LEGEND**

- ⊕ DUPLEX OUTLET
- ⊕ 5 AMP
- ⊕ GUANO OUTLET
- ⊕ DUPLEX OUTLET
- ⊕ WEATHERROOF
- ⊕ DUPLEX OUTLET
- ⊕ CEILING MOUNTED
- ⊕ DUPLEX OUTLET
- ⊕ ELECTRIC MOUNTED
- ⊕ E/M/O
- ⊕ DUPLEX OUTLET
- ⊕ FLOOR MOUNTED
- ⊕ OUTLET MOUNTED
- ⊕ GROUND FAULT INT.
- ⊕ 42" AFF.
- ⊕ 220V AC
- ⊕ SMOKE
- ⊕ DETECTOR
- ⊕ JUNCTION BOX
- ⊕ CONNECTION
- ⊕ ELECTRICAL
- ⊕ PANELBOARD

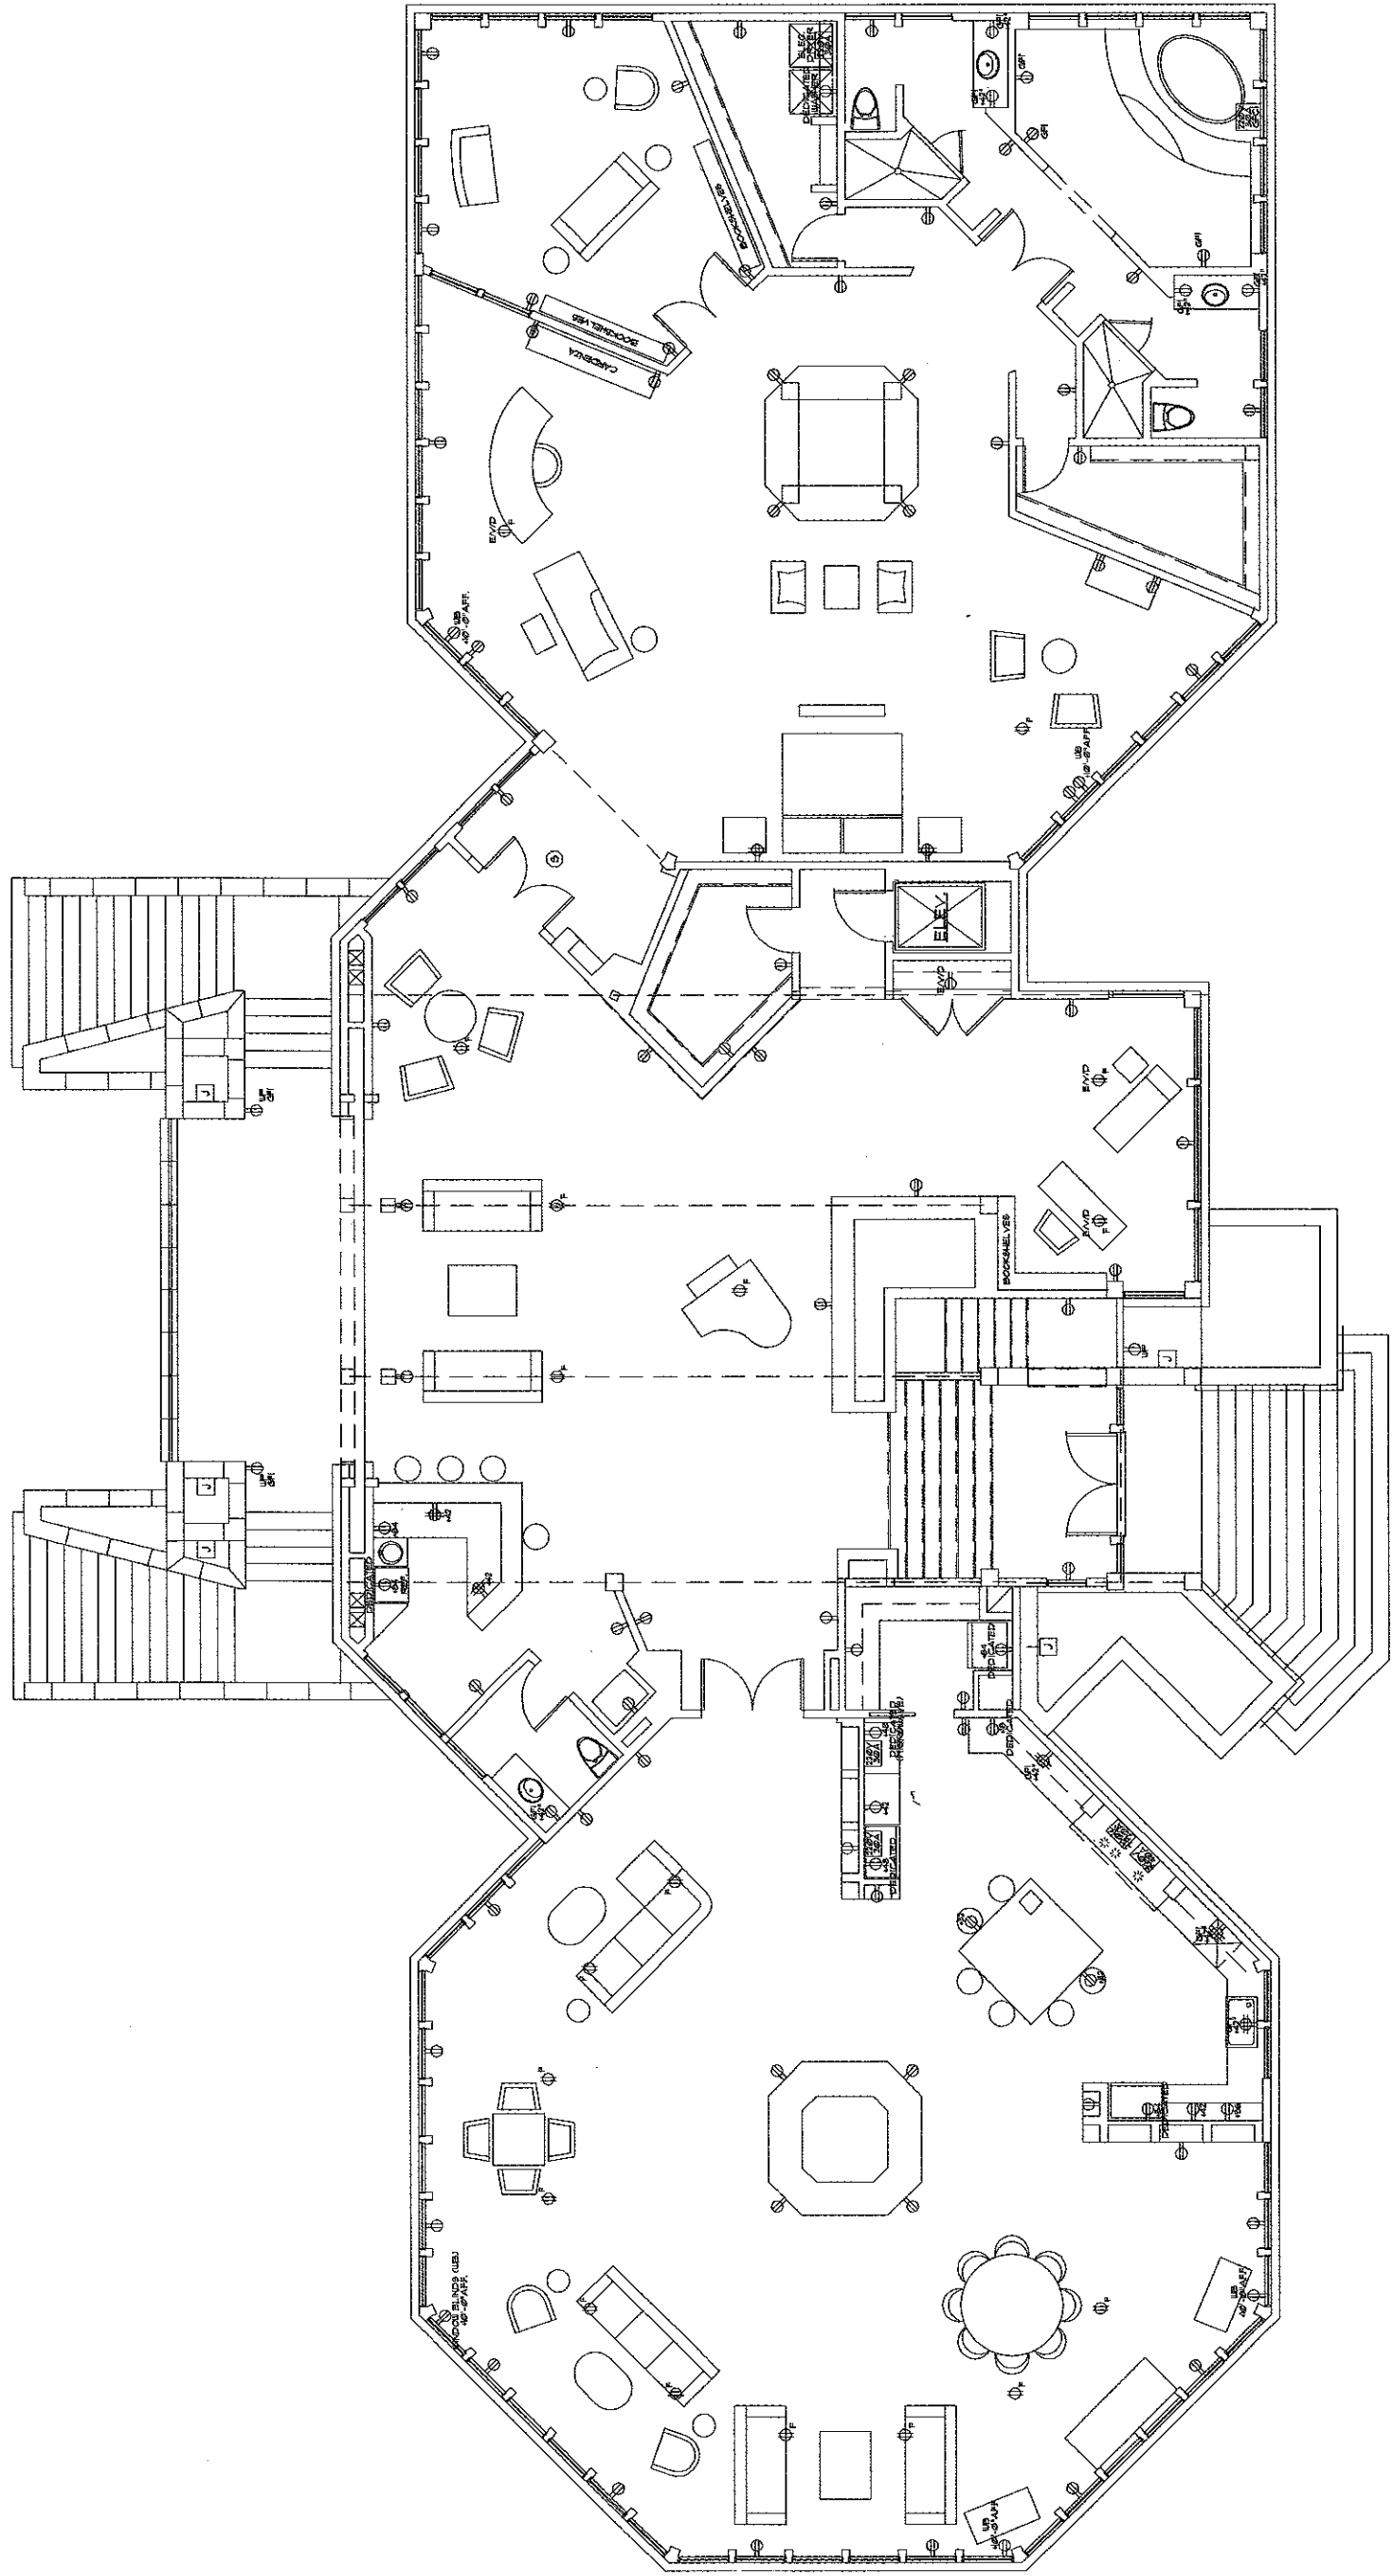

MAIN FLOOR POWER PLAN
 SCALE: 3/8" = 1'-0"
 1/8" = 1'-0" FINISHED

2-1-1
 1500002
CHATEAU DE ESLE
 1401 Greystone, Fauquier County, VA

FOR CONSTRUCTION
 01-01-2005

Architect Michael L. Oxman and Associates Ltd.

3669 Chertsey Lane
 Herndon, VA 22061
 Phone: 703-441-7443
 Fax: (703) 668-9000
 E-Mail: info@oxman.com
 www.oxman.com

This drawing is the property of Michael L. Oxman and Associates Ltd. and is to be used only for the project and location shown. It is to be used for any other use without the written permission of the architect.
 © 2005 Michael L. Oxman and Associates Ltd.